


P. E. CENTRE GROUND FLOOR PLAN

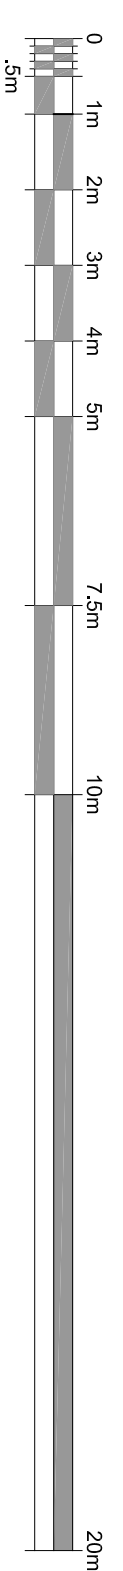

Rev	Date	Description	By
-	-	-	-

Client
DULWICH COLLEGE

Project Title
DULWICH COLLEGE
LONDON, SE21 7LD
Drawing Title
P. E. CENTRE
GROUND FLOOR PLAN

Scale	Sheet Size
1:1000/1:200	A1/A3
Approved by	Drawn by
NJ	JW
Revision	Drawn No.
-	7_237
-	1276

SCP ARCHITECTS LTD



AGENT HOUSE,
NORTHWOOD HILLS,
MIDDLESEX, HA6 1LN,
Telephone: 01823 840078
Fax: 01823 840078

This drawing is property of SCP Architects Ltd © and must not be
reproduced or used in any way without the written consent of SCP
on site before commencing work. No dimensions to be scaled from
this drawing. This drawing was produced using AutoCAD 2008.

GENERAL ARRANGEMENT